



PLUMBING FIXTURE SCHEDULE

- STANDARD TOILET
820-15/820-26 MANSFIELD ELONGATED TOILET
2015-EL TRADESTAR WOOD SEAT
- STANDARD LAVATORY
L-1390 TRADESTAR 18" ROUND LAVATORY
4771L CFG SINGLE LEVER FAUCET
- STANDARD KITCHEN SINK
K23322-4 KINGSFORD SINK
47513B CFG SINGLE LEVER FAUCET W/ SPRAY
- STANDARD TUB
7502 BATHCRAFT APD TUB & SHOWER
40314C/45312 CFG SINGLE LEVER VALVE
2251 AB&A LIFT & TURN
- WATER HEATER
M24058DS BRADFORD WHITE 40 GALLON HEATER (2 BEDROOM UNIT)
M25078DS BRADFORD WHITE 50 GALLON HEATER (3 BEDROOM UNIT)
- WASHING MACHINE BOX
OATLEY CPVC WASHER BOX W/ ARRESTORS
- ICEMAKER MACHINE BOX
OATLEY CPVC ICEMAKER BOX W/ ARRESTORS
- 38602 OATLEY CPVC ICEMAKER BOX W/ ARRESTORS

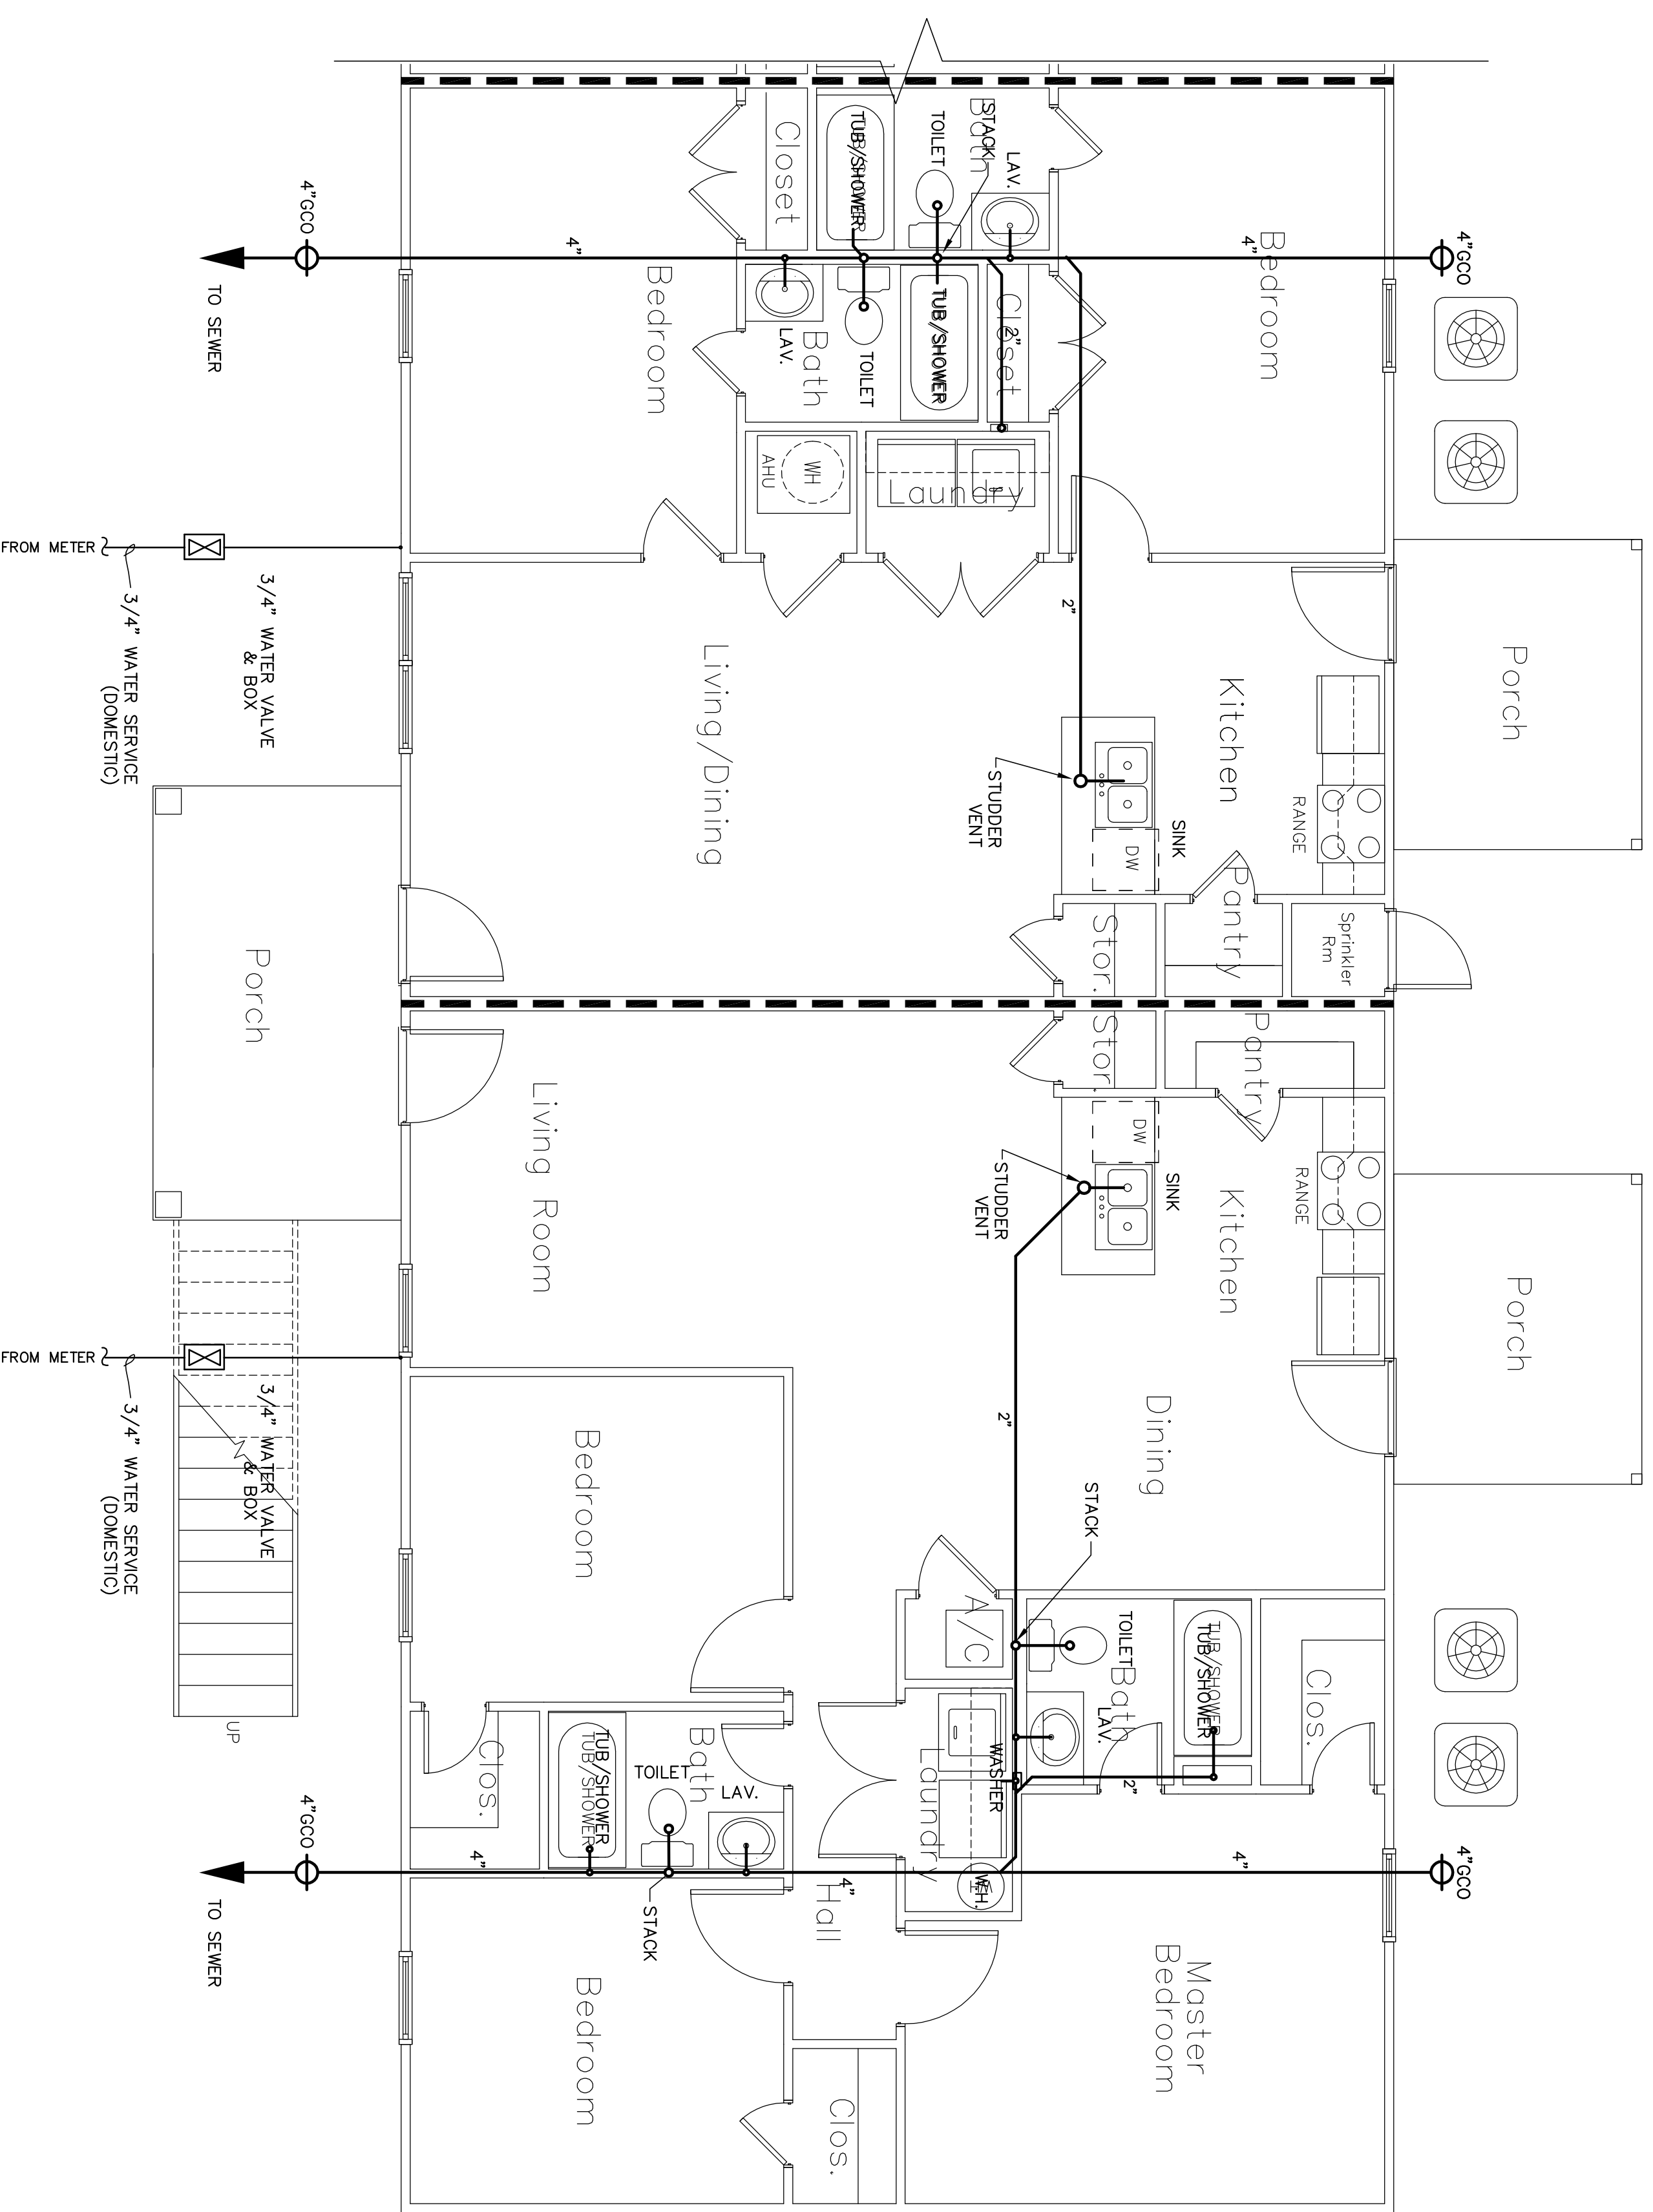

Plumbing Plan - Typical 2 & 3 Bedroom Layout
Scale: 1/4" = 1'-0"

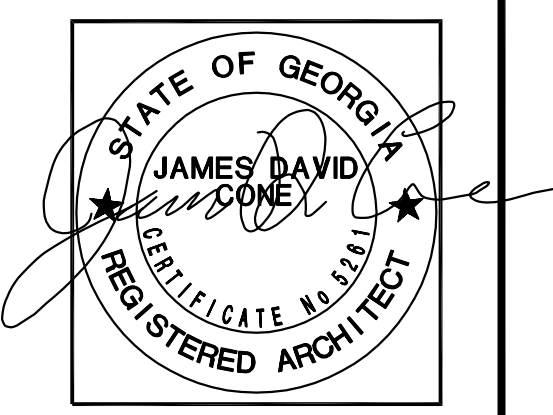

JAMES D. CONE
ARCHITECT

1806 PLUM STREET VALDOSTA, GA. 31601 TELE (229) 247-8378 FAX (229) 245-9311 E-mail JIMMY_CMA@BELLSOUTH.NET

Casey's Court Apartments
For
Charlie Hand
Tifton, Georgia

DRAWING NUMBER
P-1.1
SHEET 9 OF 11

DRAWN _____ JAC
 CHECKED _____ JAC
 JOB NUMBER 1744
 DATE Nov. 29, 2017
 REVISIONS _____
 THESE DRAWINGS ARE THE PROPERTY OF JAMES D. CONE ARCHITECT. NO REPRODUCTION OR TRANSMISSION IN ANY FORM OR BY ANY MEANS, ELECTRONIC OR MECHANICAL, INCLUDING PHOTOCOPYING, RECORDING, OR BY ANY INFORMATION STORAGE AND RETRIEVAL SYSTEM, IS PERMITTED WITHOUT THE WRITTEN PERMISSION AND CREDIT.