


West Gordon Street

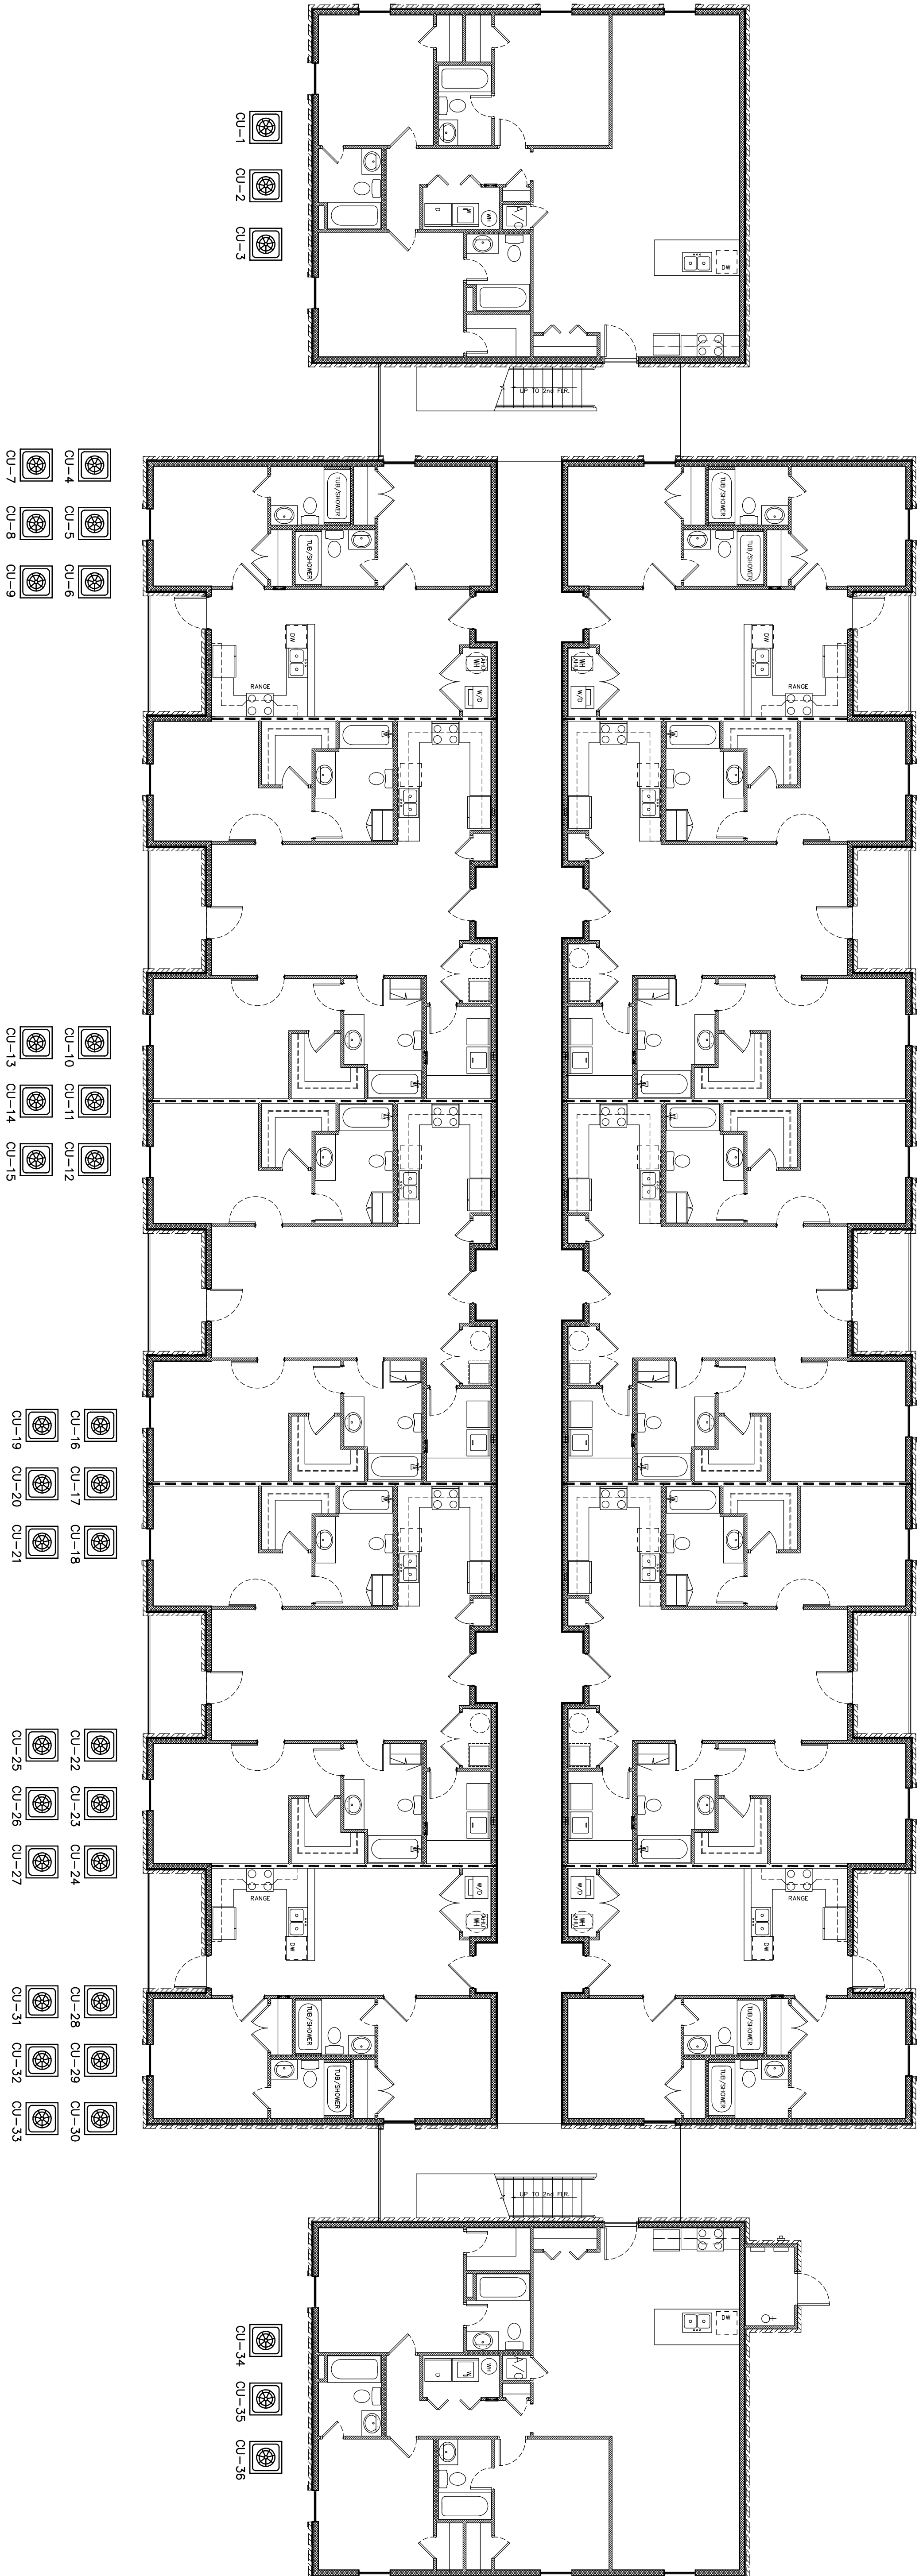

HVAC Plan - Building "B" 1st Floor

Scale: 1/8" = 1'-0"

CU-4
CU-5
CU-6
CU-7
CU-8
CU-9

CU-10
CU-11
CU-12
CU-13
CU-14
CU-15

CU-16
CU-17
CU-18
CU-19
CU-20
CU-21

CU-22
CU-23
CU-24
CU-25
CU-26
CU-27

CU-28
CU-29
CU-30
CU-31
CU-32
CU-33

CU-34
CU-35
CU-36


A New Apartment Complex
For
Remerton Mill Apartments

1853 W. Gordon Street

Remerton, Georgia

JAMES D. CONE
ARCHITECT

1806 PLUM STREET VALDOSTA, GA. 31601 TELE (229) 247-8378 FAX (229) 245-9311 E-mail JIMMY_CMA@BELLSOUTH.NET

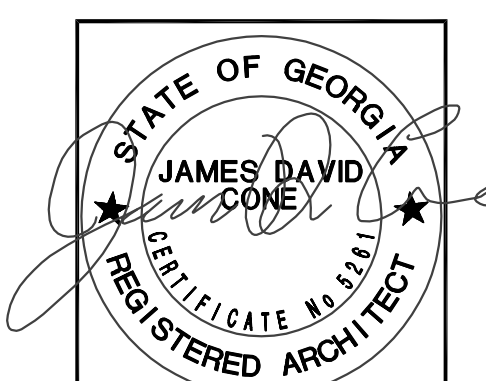

DRAWING NUMBER
M-2.2

SHEET 25 OF 47

DRAWN: M. J. J.
CHECKED: J. S. J.
JOB NUMBER: 17-20
DATE: JUNE 8, 2011
REVISIONS:
THESE DRAWINGS ARE THE PROPERTY OF JAMES D. CONE ARCHITECT. NO REPRODUCTION OR TRANSMISSION IN ANY FORM OR BY ANY MEANS IS PERMITTED WITHOUT THE WRITTEN PERMISSION AND CREDIT.