



Plumbing Fixture Schedule

P-1	WATER CLOSET 820-15/60-26 MANSFIELD ENGLIGHTED TOILET 2015-EL TRADSTAR WOOD SEAT
P-2	LAVATORY L-1380 TRADSTAR 18" ROUND LAVATORY 4771L OFG SINGLE LEVER FAUCET
P-3	TUB SHOWER 7502 BAYHURST AEO TUB & SHOWER 4771L OFG SINGLE LEVER FAUCET 2251 V884 LFT & TUBIN
P-4	2 COMP SINK K2332-4 KINGSTON SINK 4751B OFG SINGLE LEVER FAUCET W/ SPRAY
P-5	ICE MAKER BOX 38602 OATLEY OFG ICEMAKER BOX W/ ARRESTORS
WMH	WASHING MACHINE HOOKUP OATLEY OFG WASHER BOX W/ ARRESTORS
WH	40 GAL WATER HEATER M2408S BRADFORD WHITE 40 GALLON HEATER

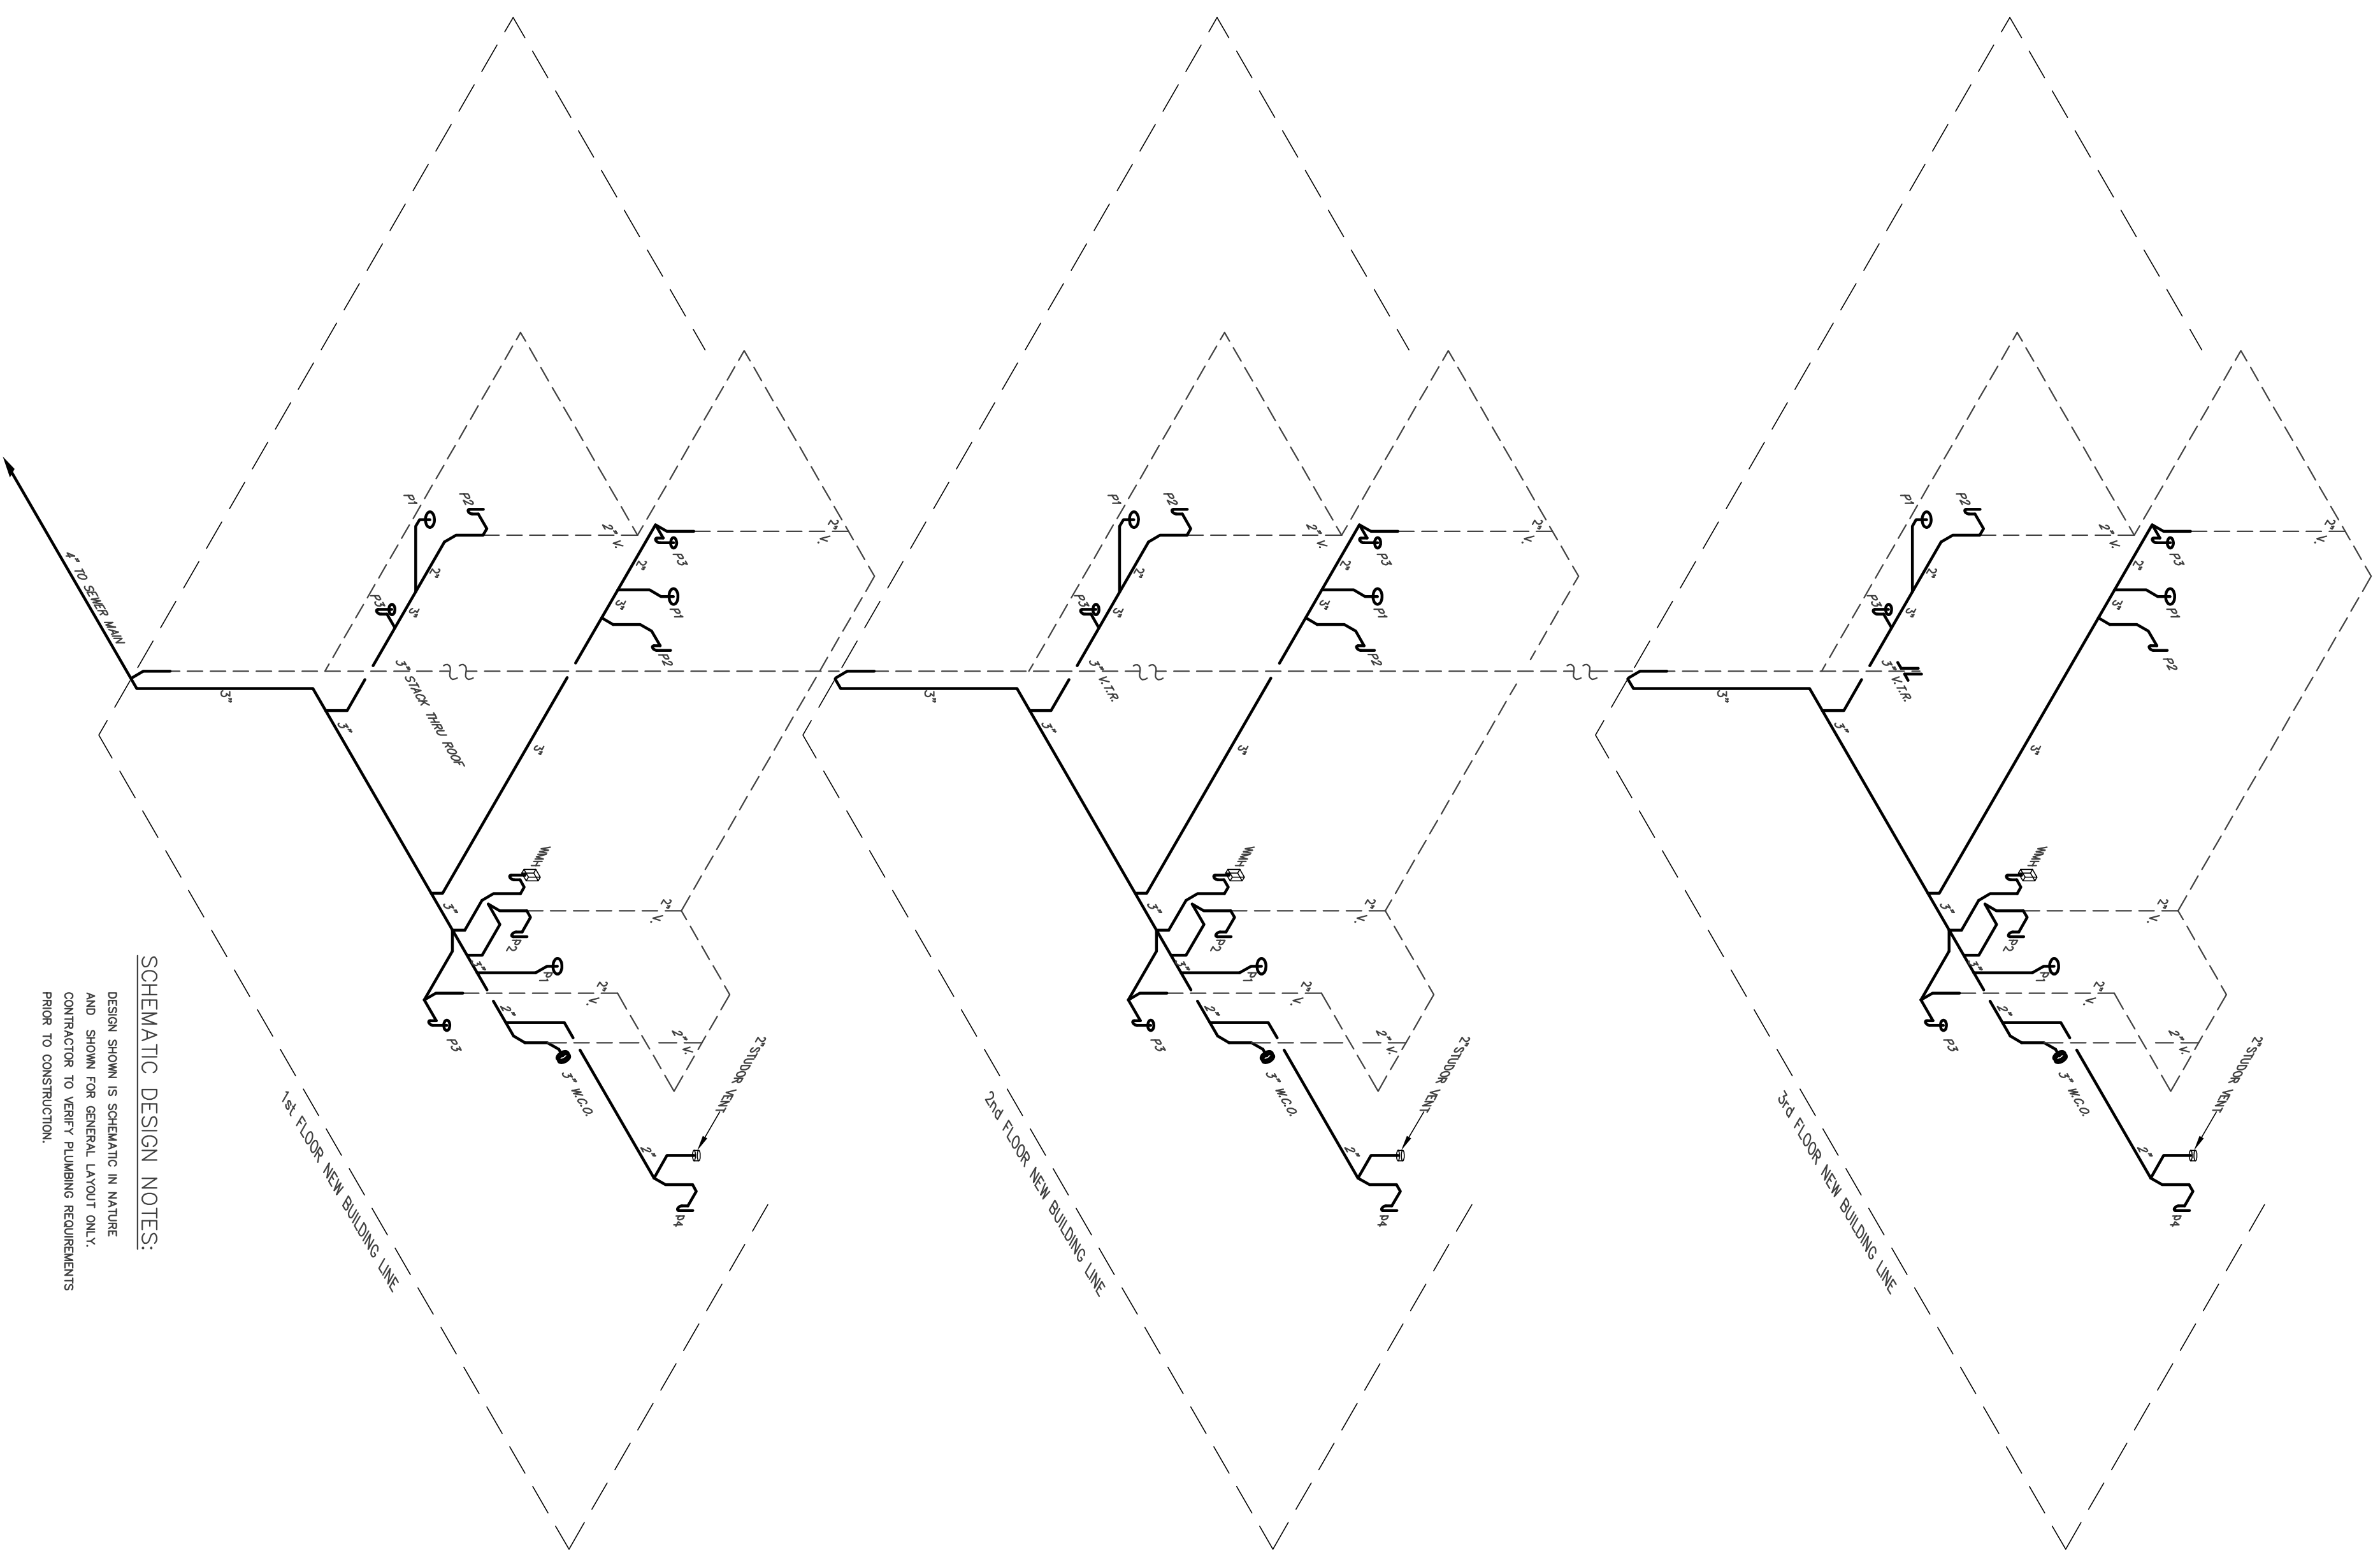

SCHEMATIC DESIGN NOTES:
DESIGN SHOWN IS SCHEMATIC IN NATURE
AND SHOWN FOR GENERAL LAYOUT ONLY.
CONTRACTOR TO VERIFY PLUMBING REQUIREMENTS
PRIOR TO CONSTRUCTION.

Plumbing Riser Diagram
Typical 3-Bedroom Unit - Bldg. "A" - 2nd & 3rd Floors
Typical 3-Bedroom Unit - Bldg. "B" - 1st, 2nd & 3rd Floors
Scale: N.T.S.

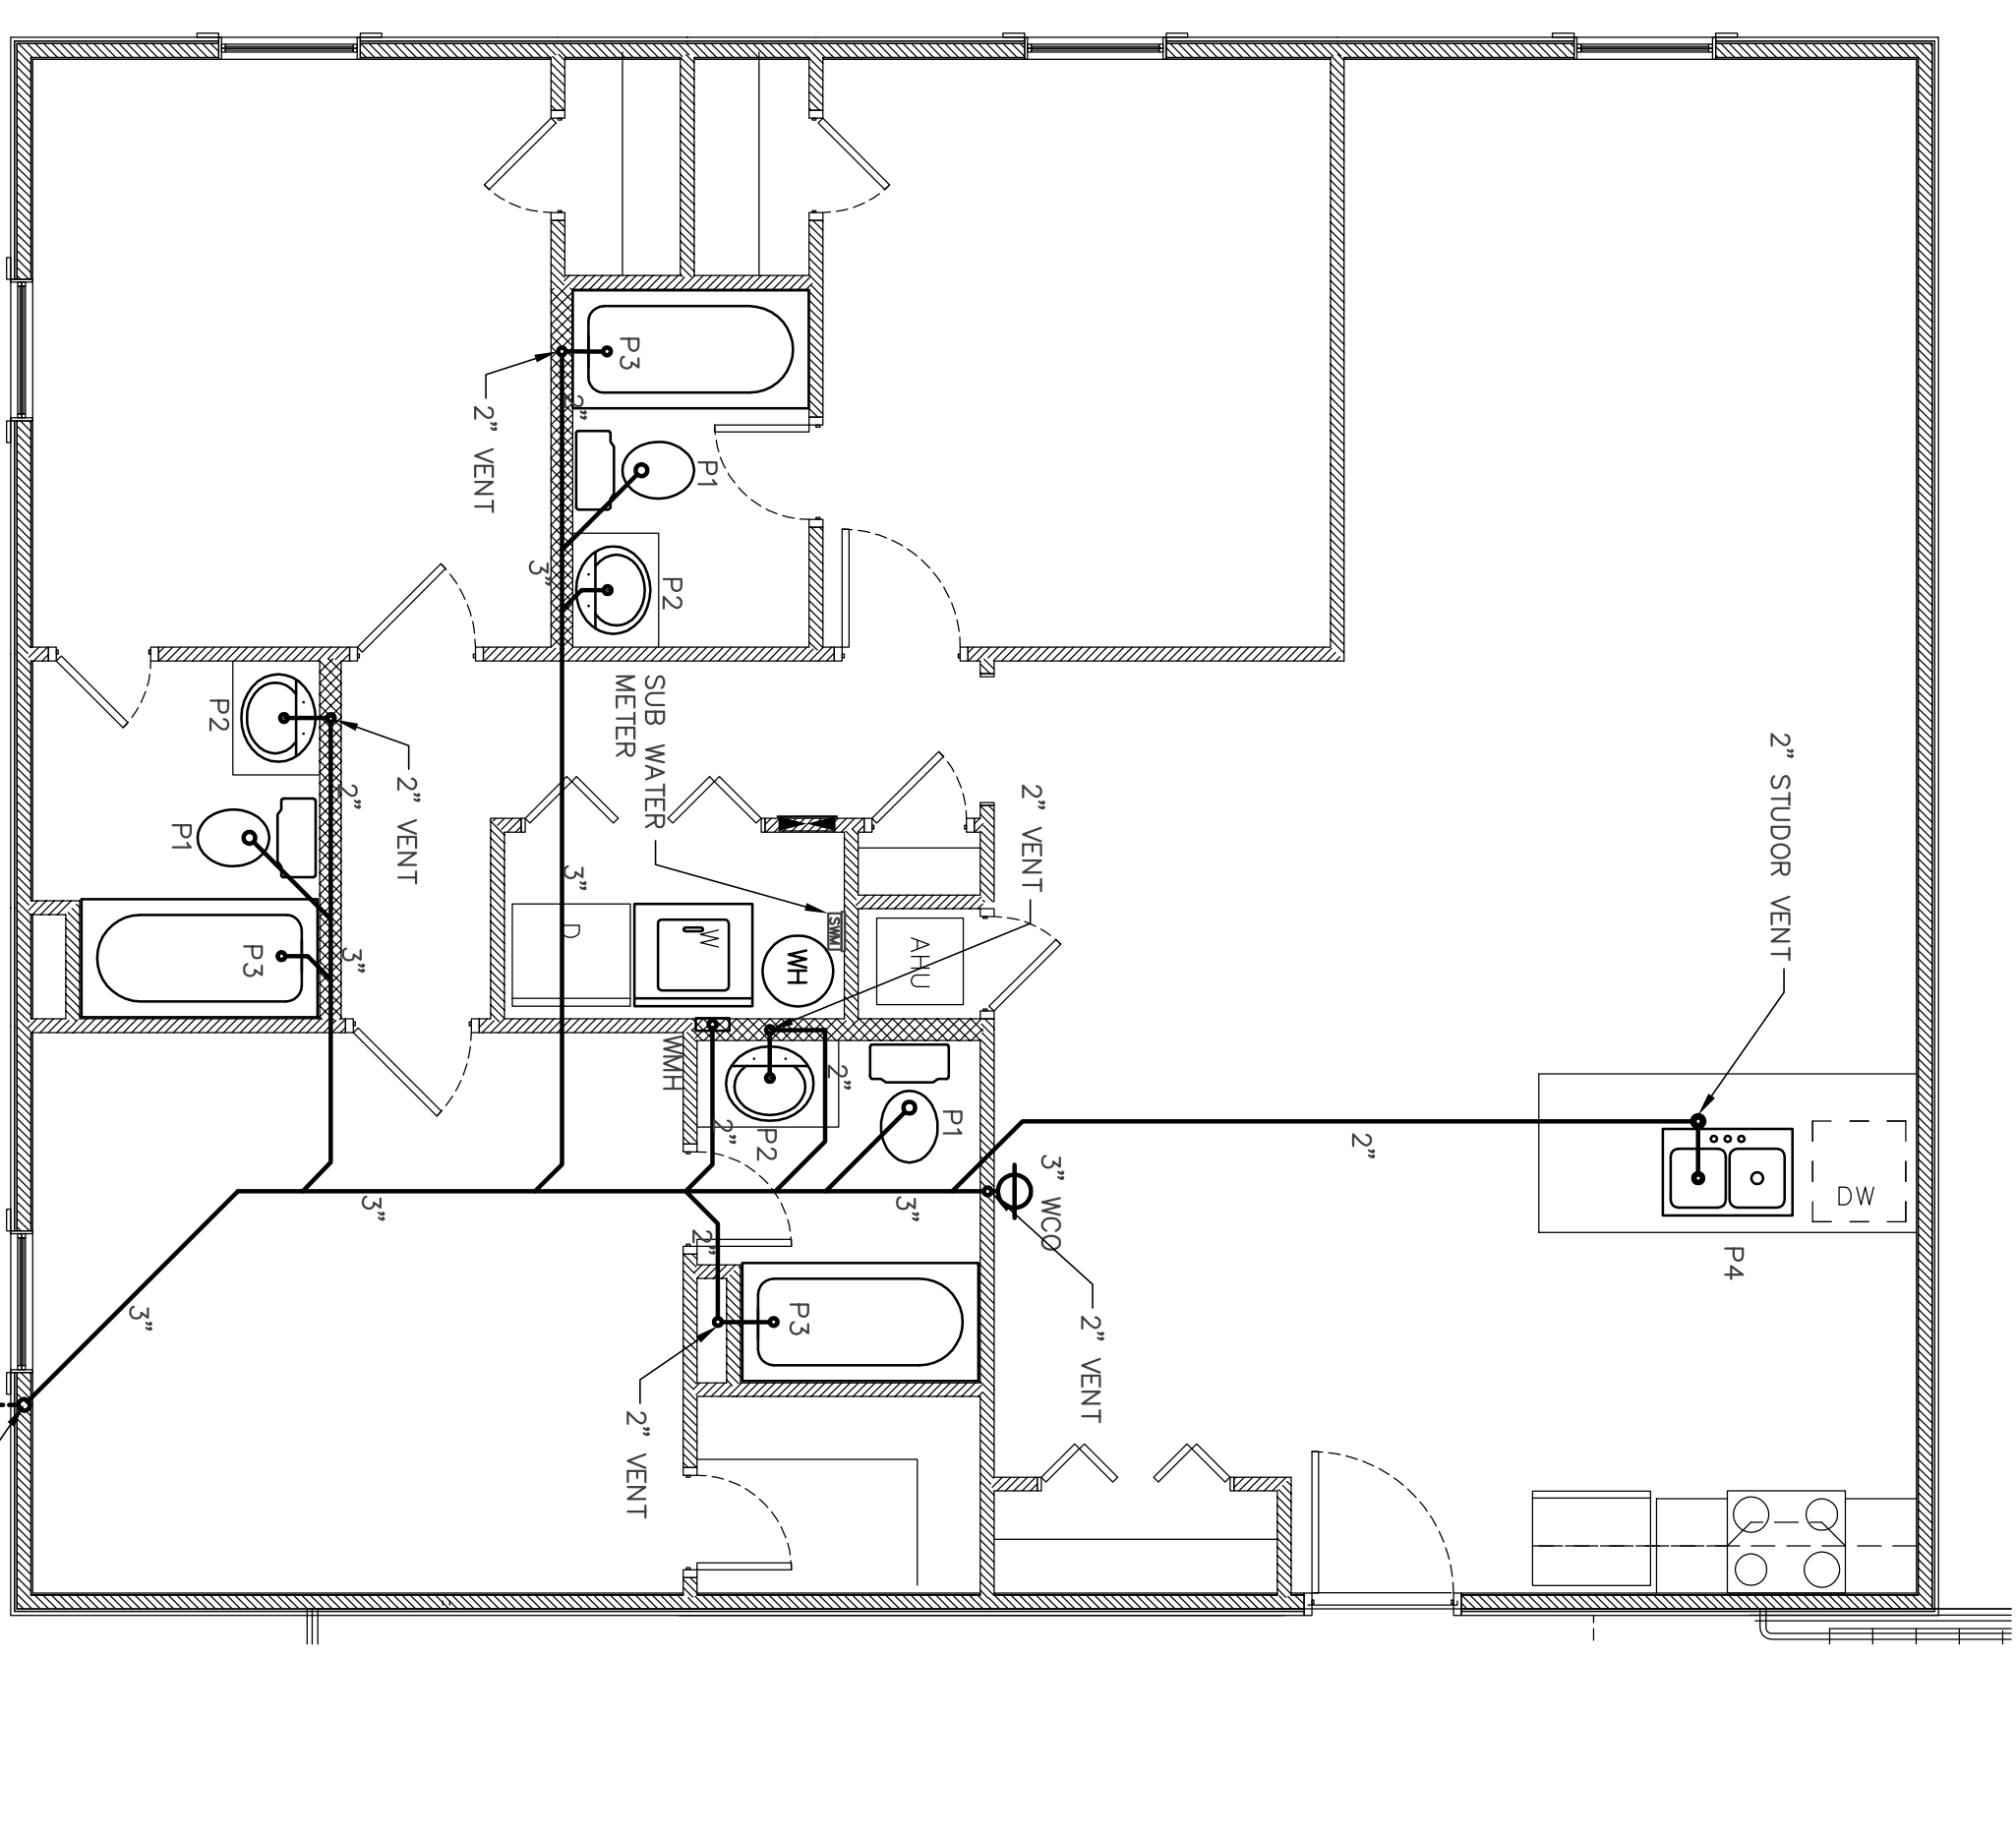


Plumbing Plan
Typical 3-Bedroom Unit - Bldg. "A" - 2nd & 3rd Floors
Typical 3-Bedroom Unit - Bldg. "B" - 1st, 2nd & 3rd Floors
Scale: 1/4" = 1'-0"

PLUMBING NOTES


1. ALL PLUMBING WORK IS TO CONFORM WITH ALL NATIONAL, STATE AND LOCAL CODES.
2. ALL INFORMATION ON PLUMBING PLANS IS BASED ON THE BEST INFORMATION AVAILABLE AT THE TIME OF DESIGN. THEREFORE FINAL LAYOUT AND DESIGN WILL BE THE SOLE RESPONSIBILITY OF THE PLUMBING CONTRACTOR.
3. PLUMBING CONTRACTOR SHALL PROVIDE THE APPLICABLE WITH SPEC. SHEETS ON ALL PLUMBING EQUIPMENT AND FIXTURES.

SCHEMATIC DESIGN NOTES:
DESIGN SHOWN IS SCHEMATIC IN NATURE
AND SHOWN FOR GENERAL LAYOUT ONLY.
CONTRACTOR TO VERIFY PLUMBING REQUIREMENTS
PRIOR TO CONSTRUCTION.

IF YOU DIG GEORGIA...
CALL US FIRST!
1-800-282-7411
UNIMATES PROTECTION CENTER
IT'S THE LAW

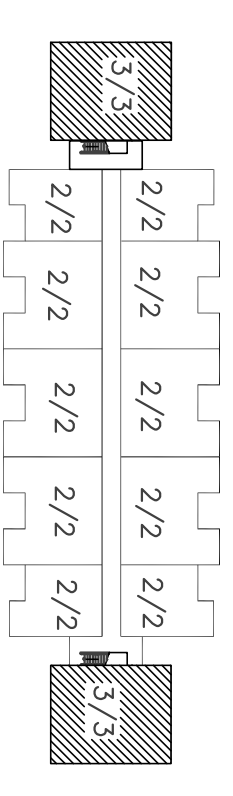

Building "A" & "B" Key

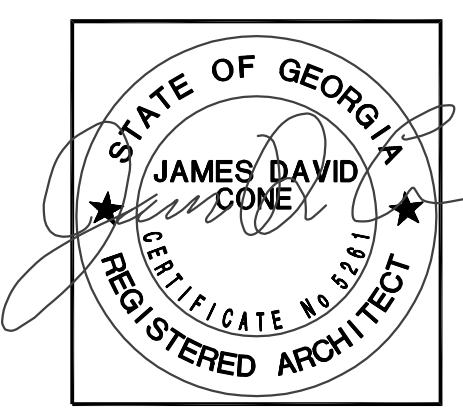

JAMES D. CONE
ARCHITECT

1806 PLUM STREET VALDOSTA, GA. 31601 TELE (229) 247-8378 FAX (229) 245-9311 E-mail JIMMY_CMA@BELLSOUTH.NET

A New Apartment Complex
For
Remerton Mill Apartments
Remerton, Georgia

1853 W. Gordon Street

DRAWING NUMBER
P-1.1
SHEET 27 OF 47

DATE: _____
CHECKED: _____
JOB NUMBER: _____
DATE: _____
REVISIONS: _____

THESE DRAWINGS ARE THE PROPERTY OF JAMES D. CONE ARCHITECT. NO REPRODUCTION OR TRANSMISSION IN ANY FORM OR BY ANY MEANS IS PERMITTED WITHOUT THE WRITTEN PERMISSION AND CREDIT.