


Plumbing Fixture Schedule

P-1	WATER CLOSET 800-15/800-28 MANSFIELD elongated TOILET 2015-EL TRADESTAR WOOD SEAT
P-2	LAVATORY L-1380 TRADESTAR 18" ROUND LAVATORY 4771L CFS SINGLE LEVER FAUCET
P-3	TUB SHOWER 7502 BATHGRANT APO TUB & SHOWER 4031W/4031Z CFS SINGLE LEVER VALVE 251 1/8x20 1/2" x 10"
P-4	2 COMP SINK K3333-4 KINGSROCK SINK 475139 CFS SINGLE LEVER FAUCET W/ SPRAY
P-5	ICE MAKER BOX 38602 OATLEY CPVC ICEMAKER BOX W/ ARRESTORS
MMH	WASHING MACHINE HOOKUP OATLEY CPVC WASHER BOX W/ ARRESTORS
WH	40 GAL WATER HEATER W42650S BRADFORD WHITE 40 GALLON HEATER

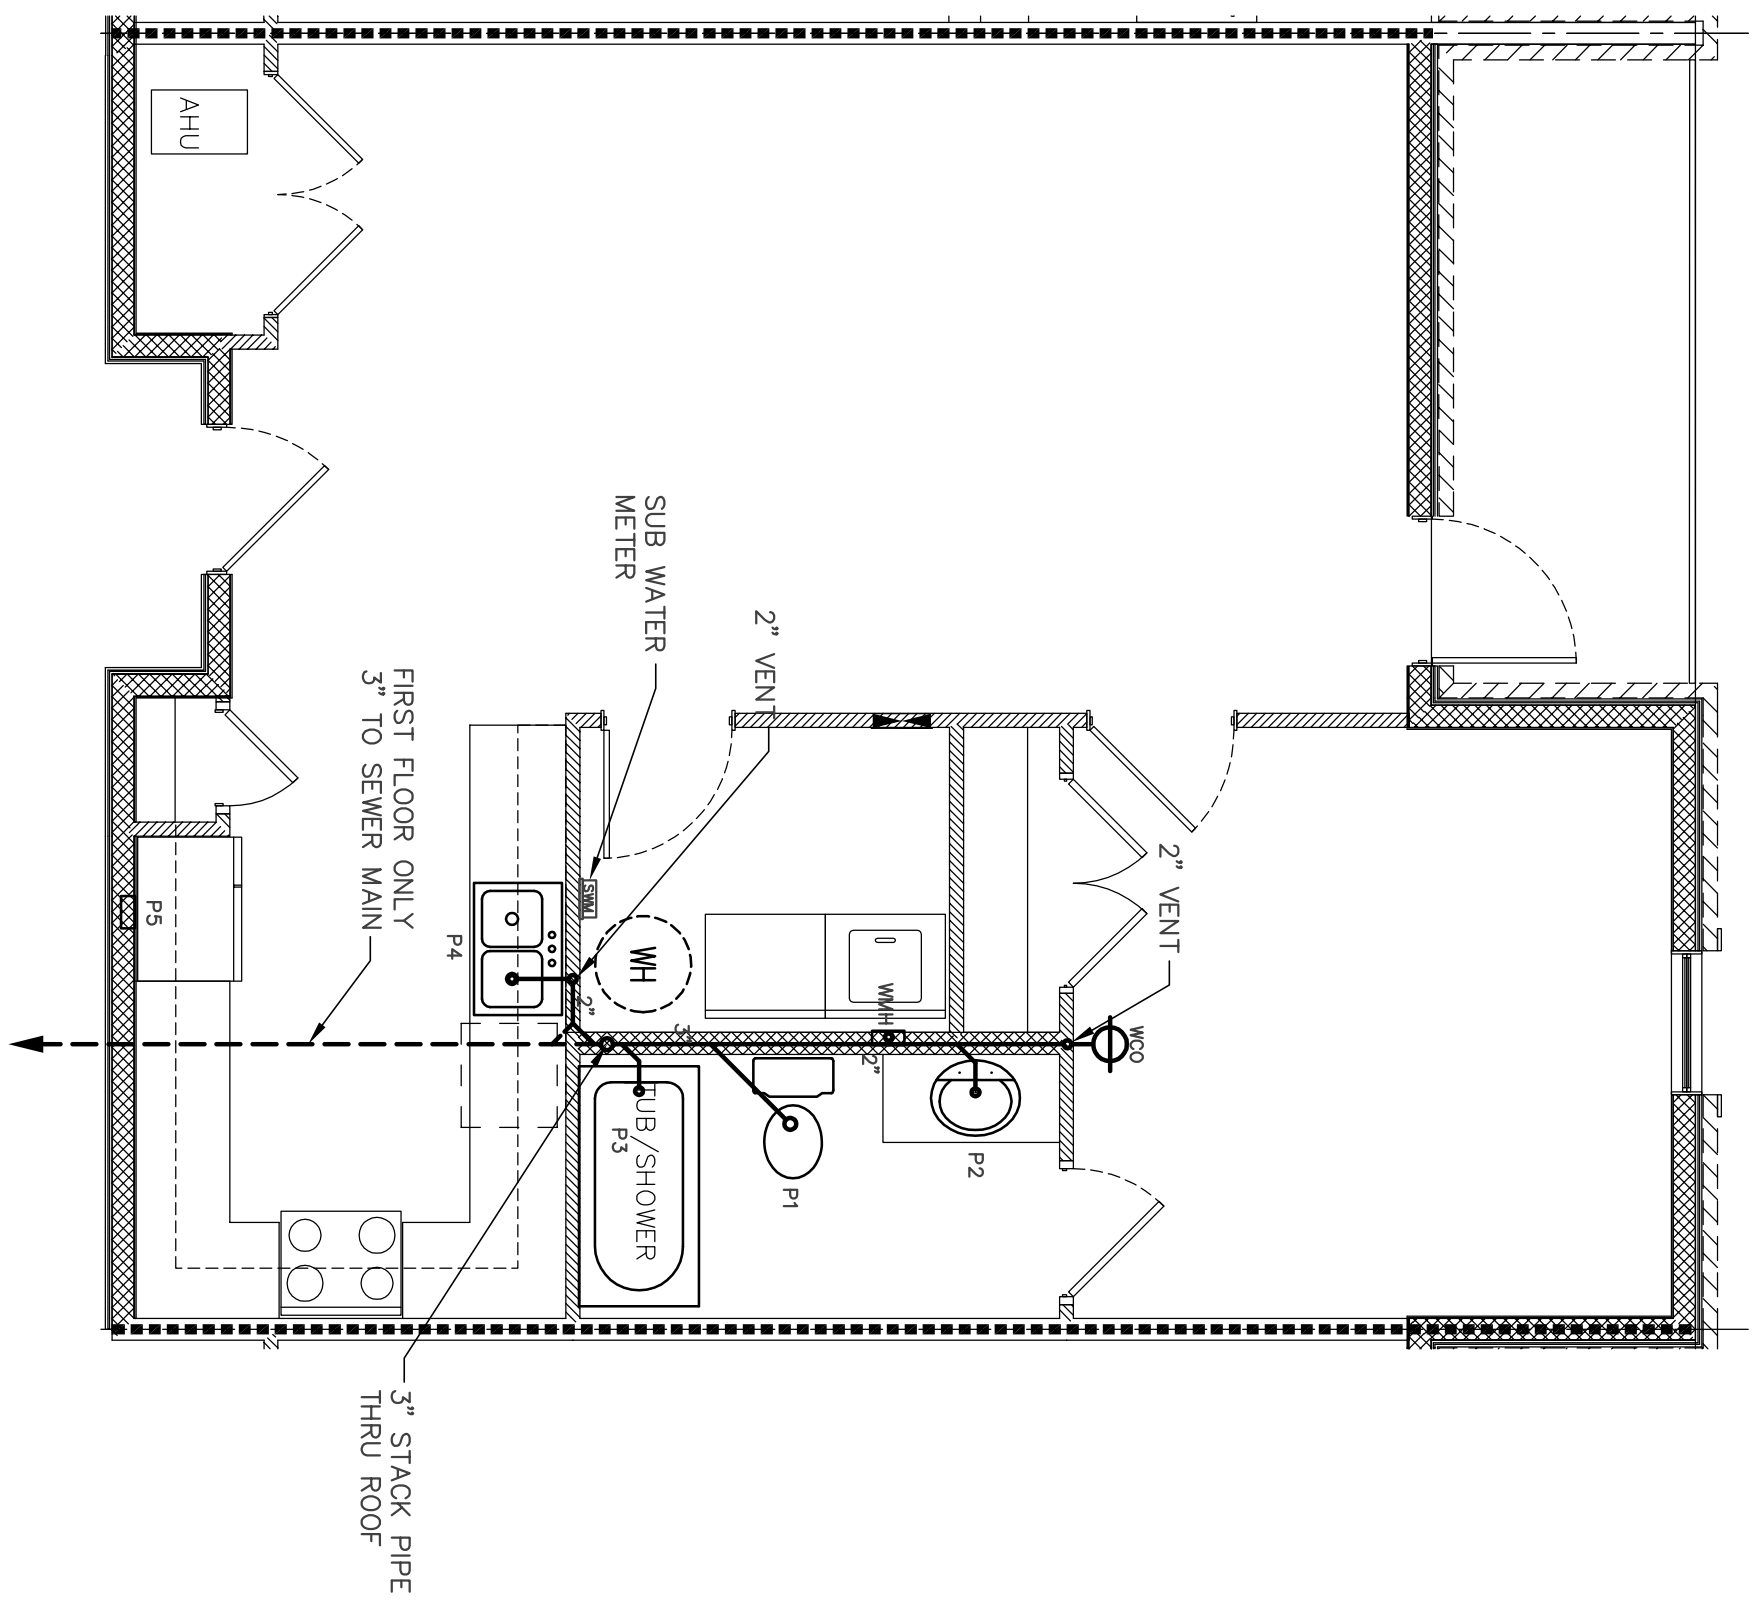


Plumbing Plan
Typical 1-Bedroom Units - Bldg. "C" - 1st, 2nd & 3rd Floors
 Scale: 1/4" = 1'-0"

PLUMBING NOTES

1. ALL PLUMBING WORK IS TO CONFORM WITH ALL NATIONAL, STATE AND LOCAL CODES AND REGULATIONS.
2. ALL INFORMATION ON PLUMBING PLANS IS BASED ON THE BEST INFORMATION AVAILABLE AT THE TIME OF DESIGN. THEREFORE, FINAL LAYOUT AND DESIGN WILL BE THE SOLE RESPONSIBILITY OF THE PLUMBING CONTRACTOR.
3. PLUMBING CONTRACTOR SHALL PROVIDE THE ARCHITECT WITH SPEC. SHEETS ON ALL PLUMBING EQUIPMENT AND FIXTURES.

SCHEMATIC DESIGN NOTES:
 DESIGN SHOWN IS SCHEMATIC IN NATURE AND SHOWN FOR GENERAL LAYOUT ONLY. CONTRACTOR TO VERIFY PLUMBING REQUIREMENTS PRIOR TO CONSTRUCTION.

IF YOU DIG, GEORGIA...
 CALL US FIRST!
 1-800-282-7411
 UTILITIES PROTECTION CENTER
 IT'S THE LAW

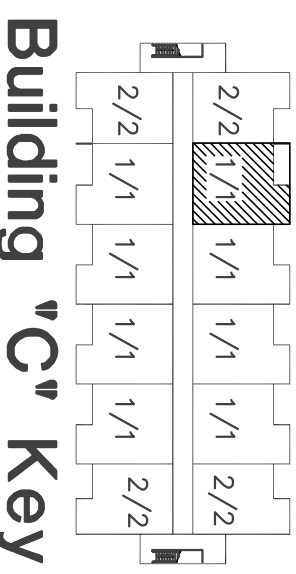

DRAWING NUMBER	P-1.4
CHECKED	AKC
JOB NUMBER	17-09
DATE	June 5, 2018
REVISIONS	

THESE DRAWINGS ARE THE PROPERTY OF JAMES D. CONE ARCHITECT. NO PART OF THESE DRAWINGS MAY BE REPRODUCED OR TRANSMITTED IN ANY FORM OR BY ANY MEANS, ELECTRONIC OR MECHANICAL, WITHOUT PERMISSION AND CREDIT.

A New Apartment Complex


For
Remerton Mill Apartments

1853 W. Gordon Street
 Remerton, Georgia

JAMES D. CONE

ARCHITECT

1806 PLUM STREET VALDOSTA, GA. 31601 TELE (229) 247-8378 FAX (229) 245-9311 E-mail JIMMY_CMA@BELLSOUTH.NET

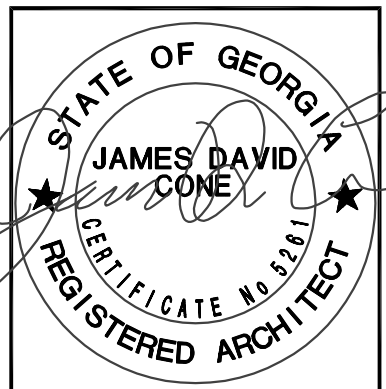

Plumbing Riser Diagram
Typical 1-Bedroom Units - Bldg. "C" - 1st, 2nd & 3rd Floors
 Scale: N.T.S.