



Plumbing Plan - Building 'A' 3rd Floor
Scale: 1/8" = 1'-0"

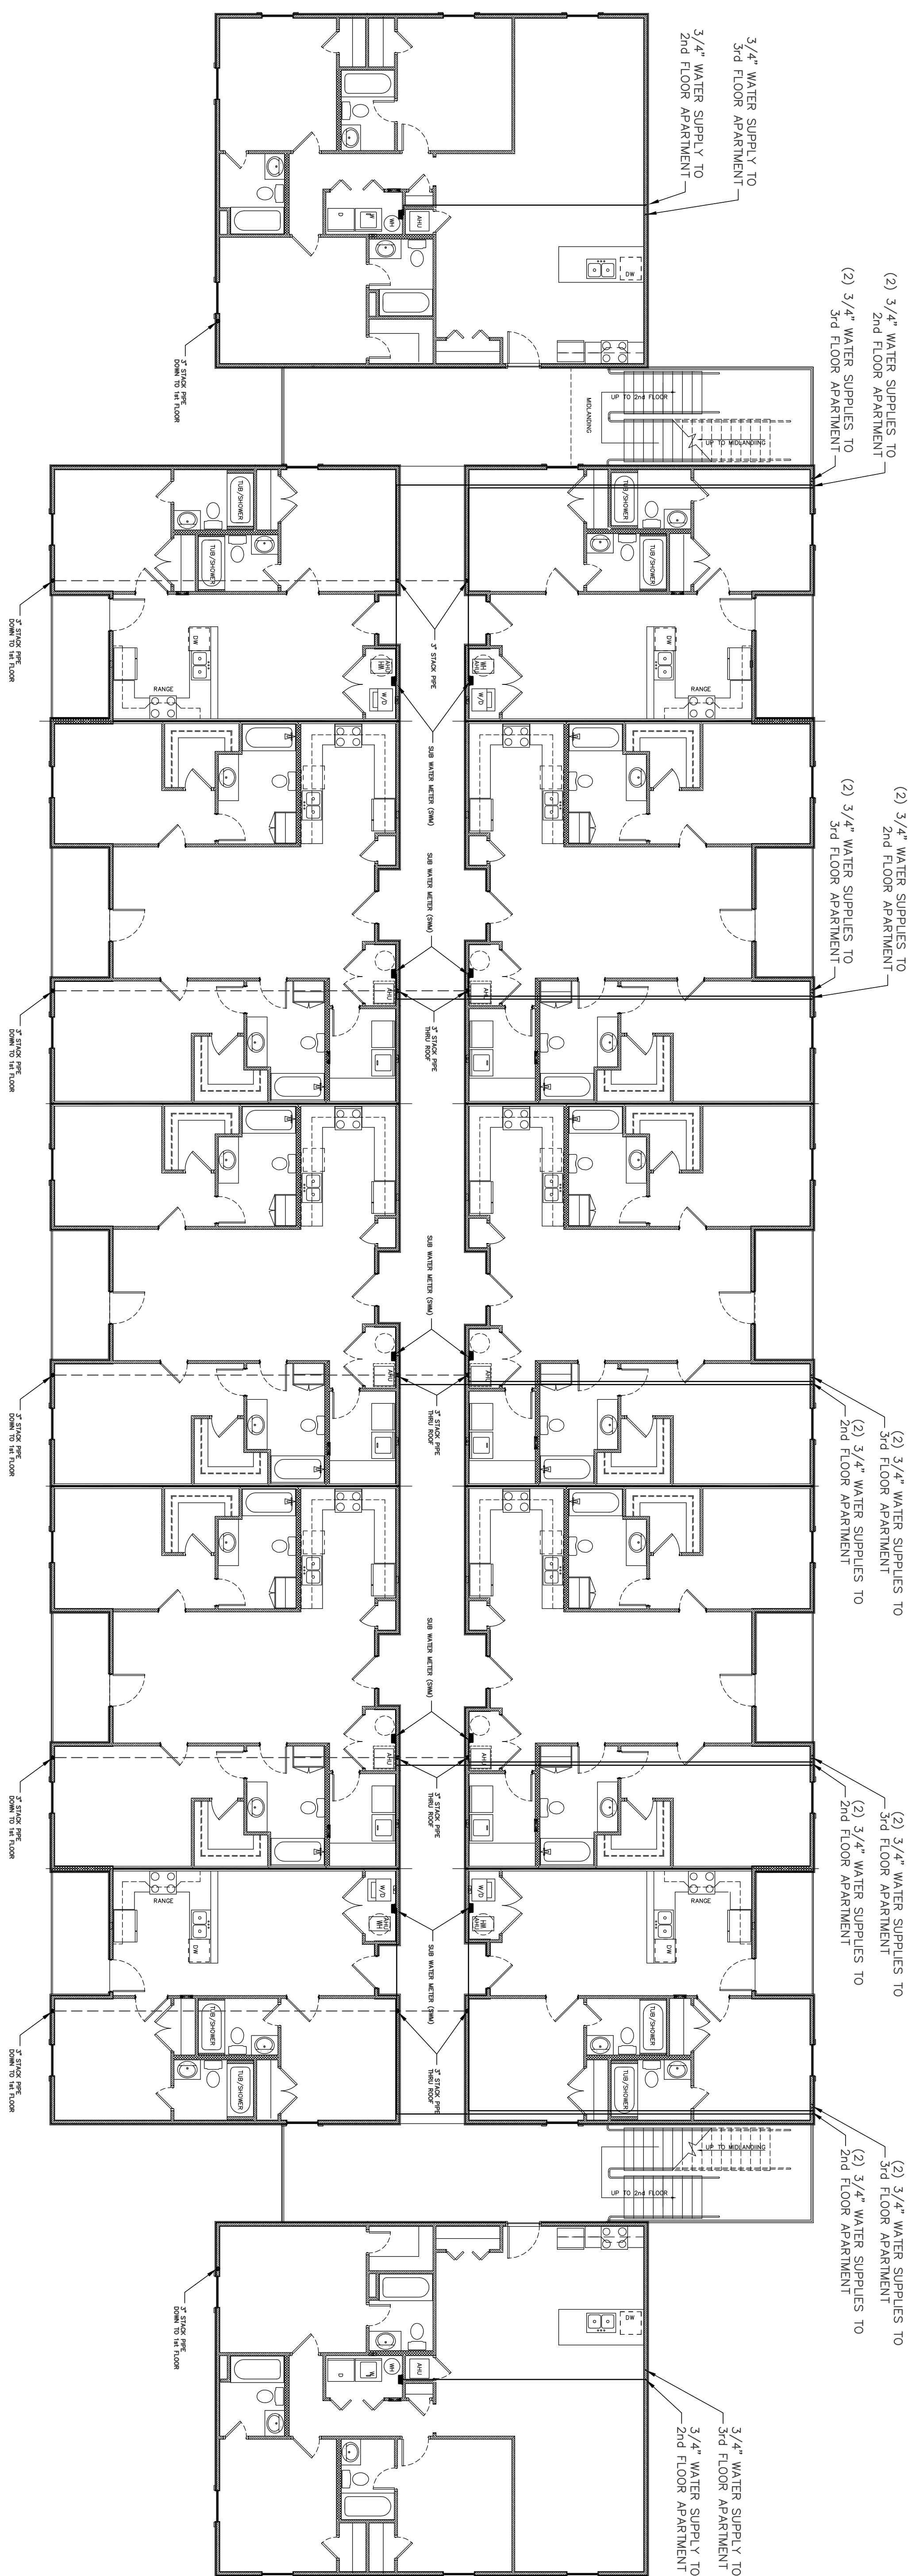

Plumbing Plan - Building 'A' 2nd Floor
Scale: 1/8" = 1'-0"

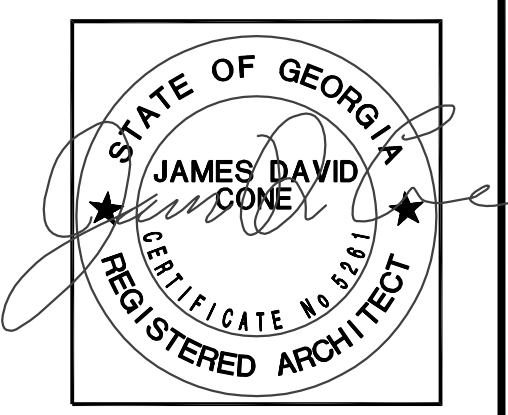

JAMES D. CONE
ARCHITECT

1806 PLUM STREET VALDOSTA, GA. 31601 TELE (229) 247-8378 FAX (229) 245-9311 E-mail JIMMY_CMA@BELLSOUTH.NET

A New Apartment Complex
For
Remerton Mill Apartments
1853 W. Gordon Street Remerton, Georgia

DRAWING NUMBER
P-2.2
SHEET 32 OF 47

DATE: _____
JOB NUMBER: _____
CHECKED: _____
DRAWN: _____

THESE DRAWINGS ARE THE PROPERTY OF JAMES D. CONE ARCHITECT. NO REPRODUCTION OR TRANSMISSION IN ANY FORM OR BY ANY MEANS IS PERMITTED WITHOUT THE WRITTEN PERMISSION AND CREDIT.